




SITE LOCATION MAP
1:2500@A1 O.S. No. 6080

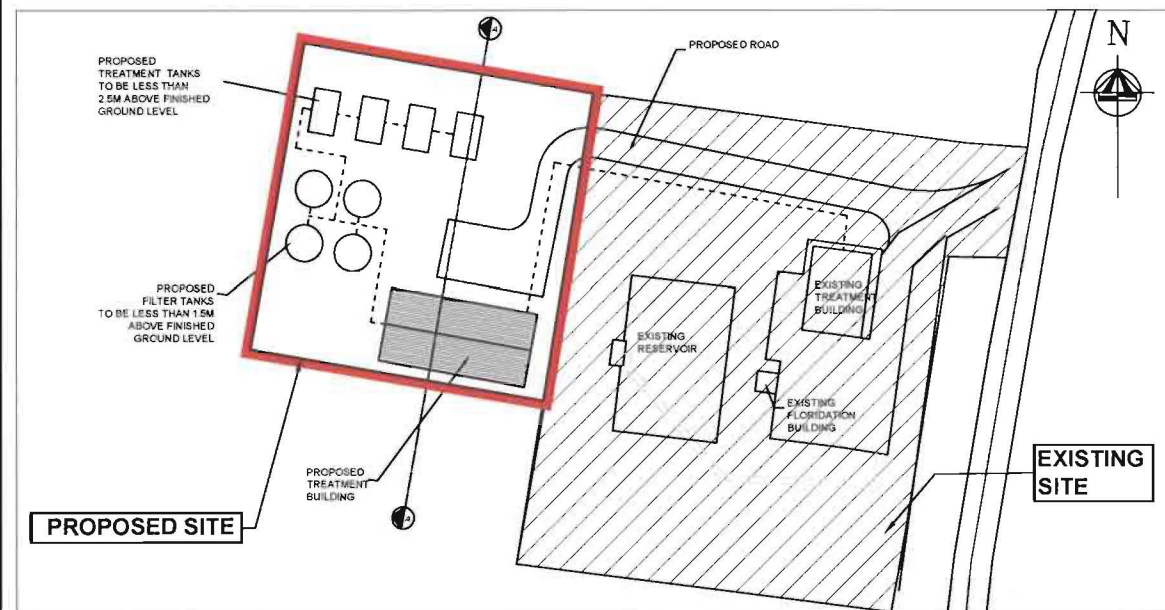


SITE LAYOUT PLAN
1:500@A1

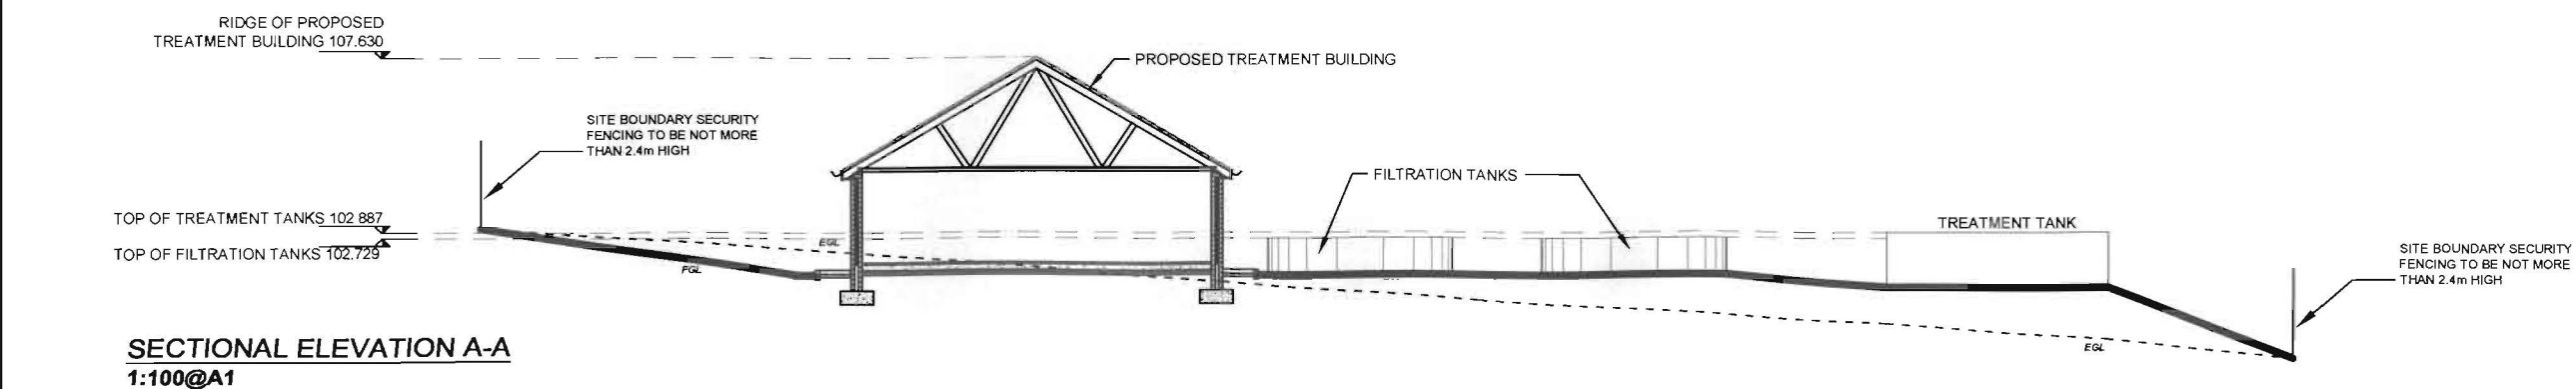

SECTIONAL ELEVATION A-A
1:100@A1

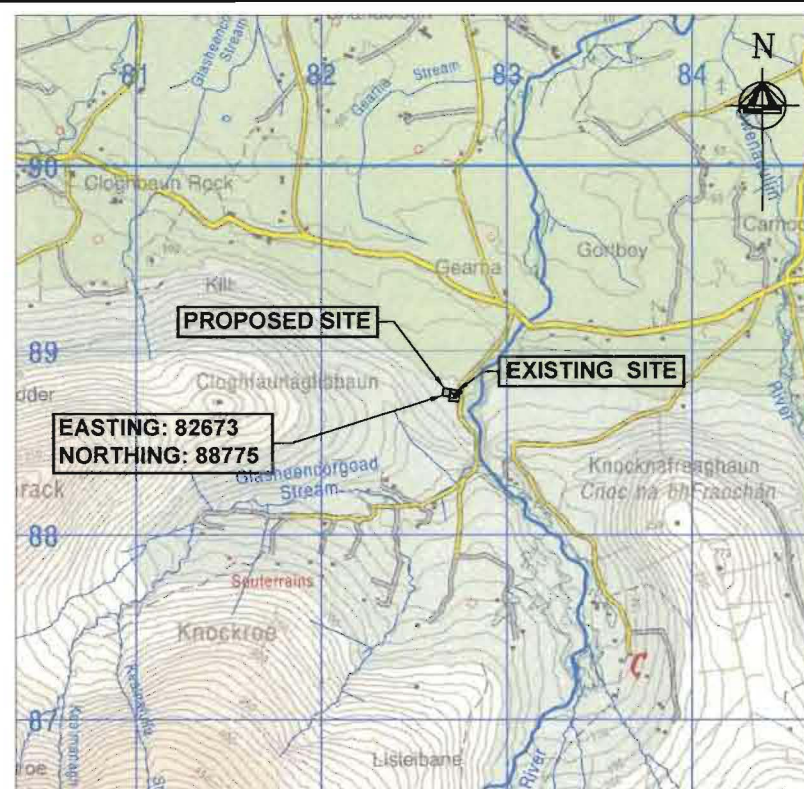


SITE LOCATION MAP
1:20,000@A1

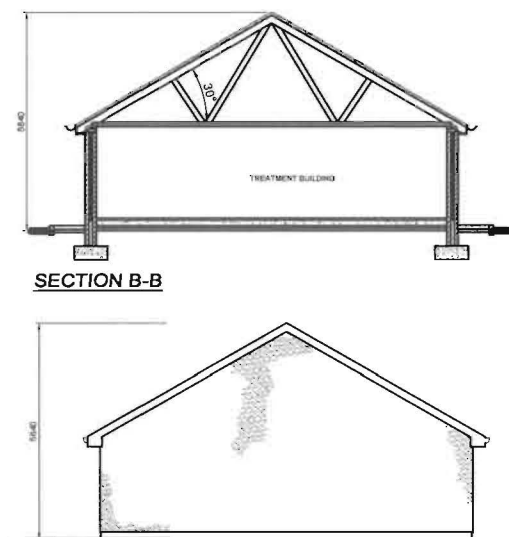


SIDE ELEVATION

TREATMENT BUILDING DETAILS
1:100@A1

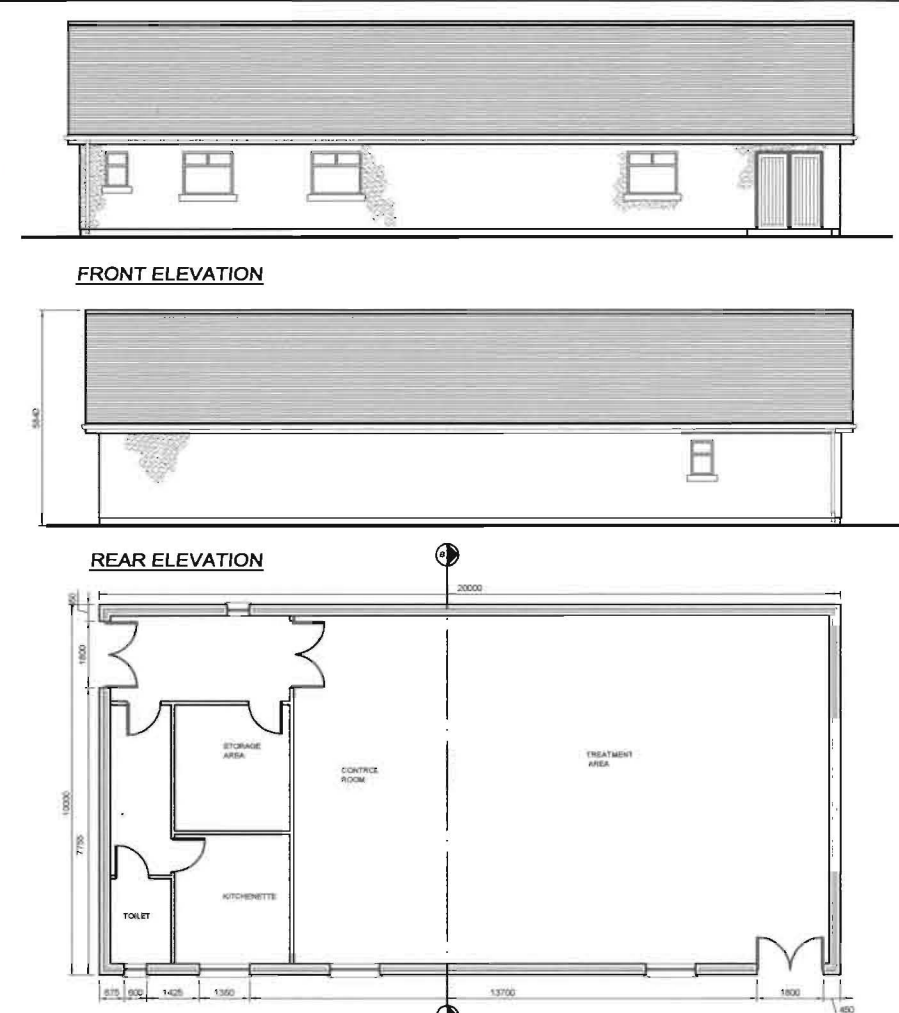

FLOOR PLAN

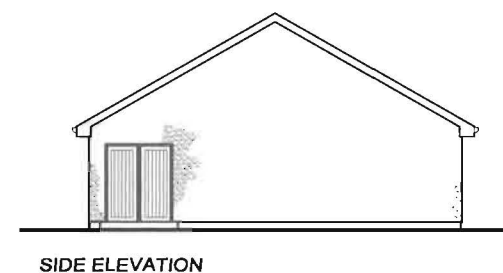

SIDE ELEVATION

NOTE:

THE DETAILS OF THE CONTROL BUILDING SHOWN ARE INDICATIVE ONLY. THE SCALE AND LAYOUT OF THE BUILDING MAY CHANGE AT DETAILED DESIGN STAGE.

THE SCALE OF THE STRUCTURE WILL NOT BE GREATER THAN THAT SHOWN BUT MAY BE REDUCED.

THE CONTROL BUILDING MAY BE CONSTRUCTED ON-SITE OR A PREFABRICATED STRUCTURE MAY BE USED.

WHERE THE CONTROL BUILDING IS CONSTRUCTED ON-SITE IT WILL HAVE A SMOOTH PLASTER FINISH EXTERNALLY, PAINTED A NEUTRAL COLOUR AND A DARK FLAT PROFILE TILE OR CLADDING TO THE ROOF.

WHERE THE CONTROL BUILDING IS PREFABRICATED IT WILL BE MANUFACTURED FROM GLASS REINFORCED PLASTIC AND SHALL BE GREEN IN COLOUR. THE PREFABRICATED CONTROL BUILDING MAY HAVE A PITCHED OR FLAT ROOF.

MAXIMUM HEIGHT OF BUILDING ABOVE FINISHED GROUND LEVEL IS TO BE 6.0m

LEGEND:
EGL - EXISTING GROUND LEVEL
FGL - FINISHED GROUND LEVEL
TWL - TOP WATER LEVEL

INDICATIVE LAYOUT ONLY

A			
Rev	By	Date	Description
1	CG	21/05/06	Issued for Public Consultation
COMHAIRLE CONTAE CHIARRAÍ SEIRBHÍSI UISCE, CAIPITEAL KERRY COUNTY COUNCIL WATER SERVICES CAPITAL Mr. G. Ring C Eng M.I.E.I. Director of Water Services County Buildings, Rathlea, Tralee, Co. Kerry Email: water@kerrycc.ie Phone: 051 7152000 Fax: 051 7152001			
Project: MID-KERRY WATER SUPPLY SCHEME			
Title: Site Location Map, Site Layout Plan Sectional Elevation & Control Building Details			
Drawn: CG	Designed: JK	Checked: BOS	Date: 03/04/2009
Scale: As Shown	Drawing No: 010004P/0001	Rev: A	